


- LEGEND**
- Fire Exit
 - FHR (Fire Hose Reel)
 - Fire Extinguisher
 - Fire Alarm Break Glass
 - Fire Escape Corridor
 - Fire Access Keep Clear Zone
 - Fire Reel & Toilet Clear Zone
 - Food & Beverage/Venues Area
 - Concourse Build Areas
 - Registration & Build Areas
 - Reduced Ceiling Height
 - Emergency Medical Services
 - Telecommunications Box
 - Female Toilet
 - Male Toilet
 - Wheelchair Accessible Toilet

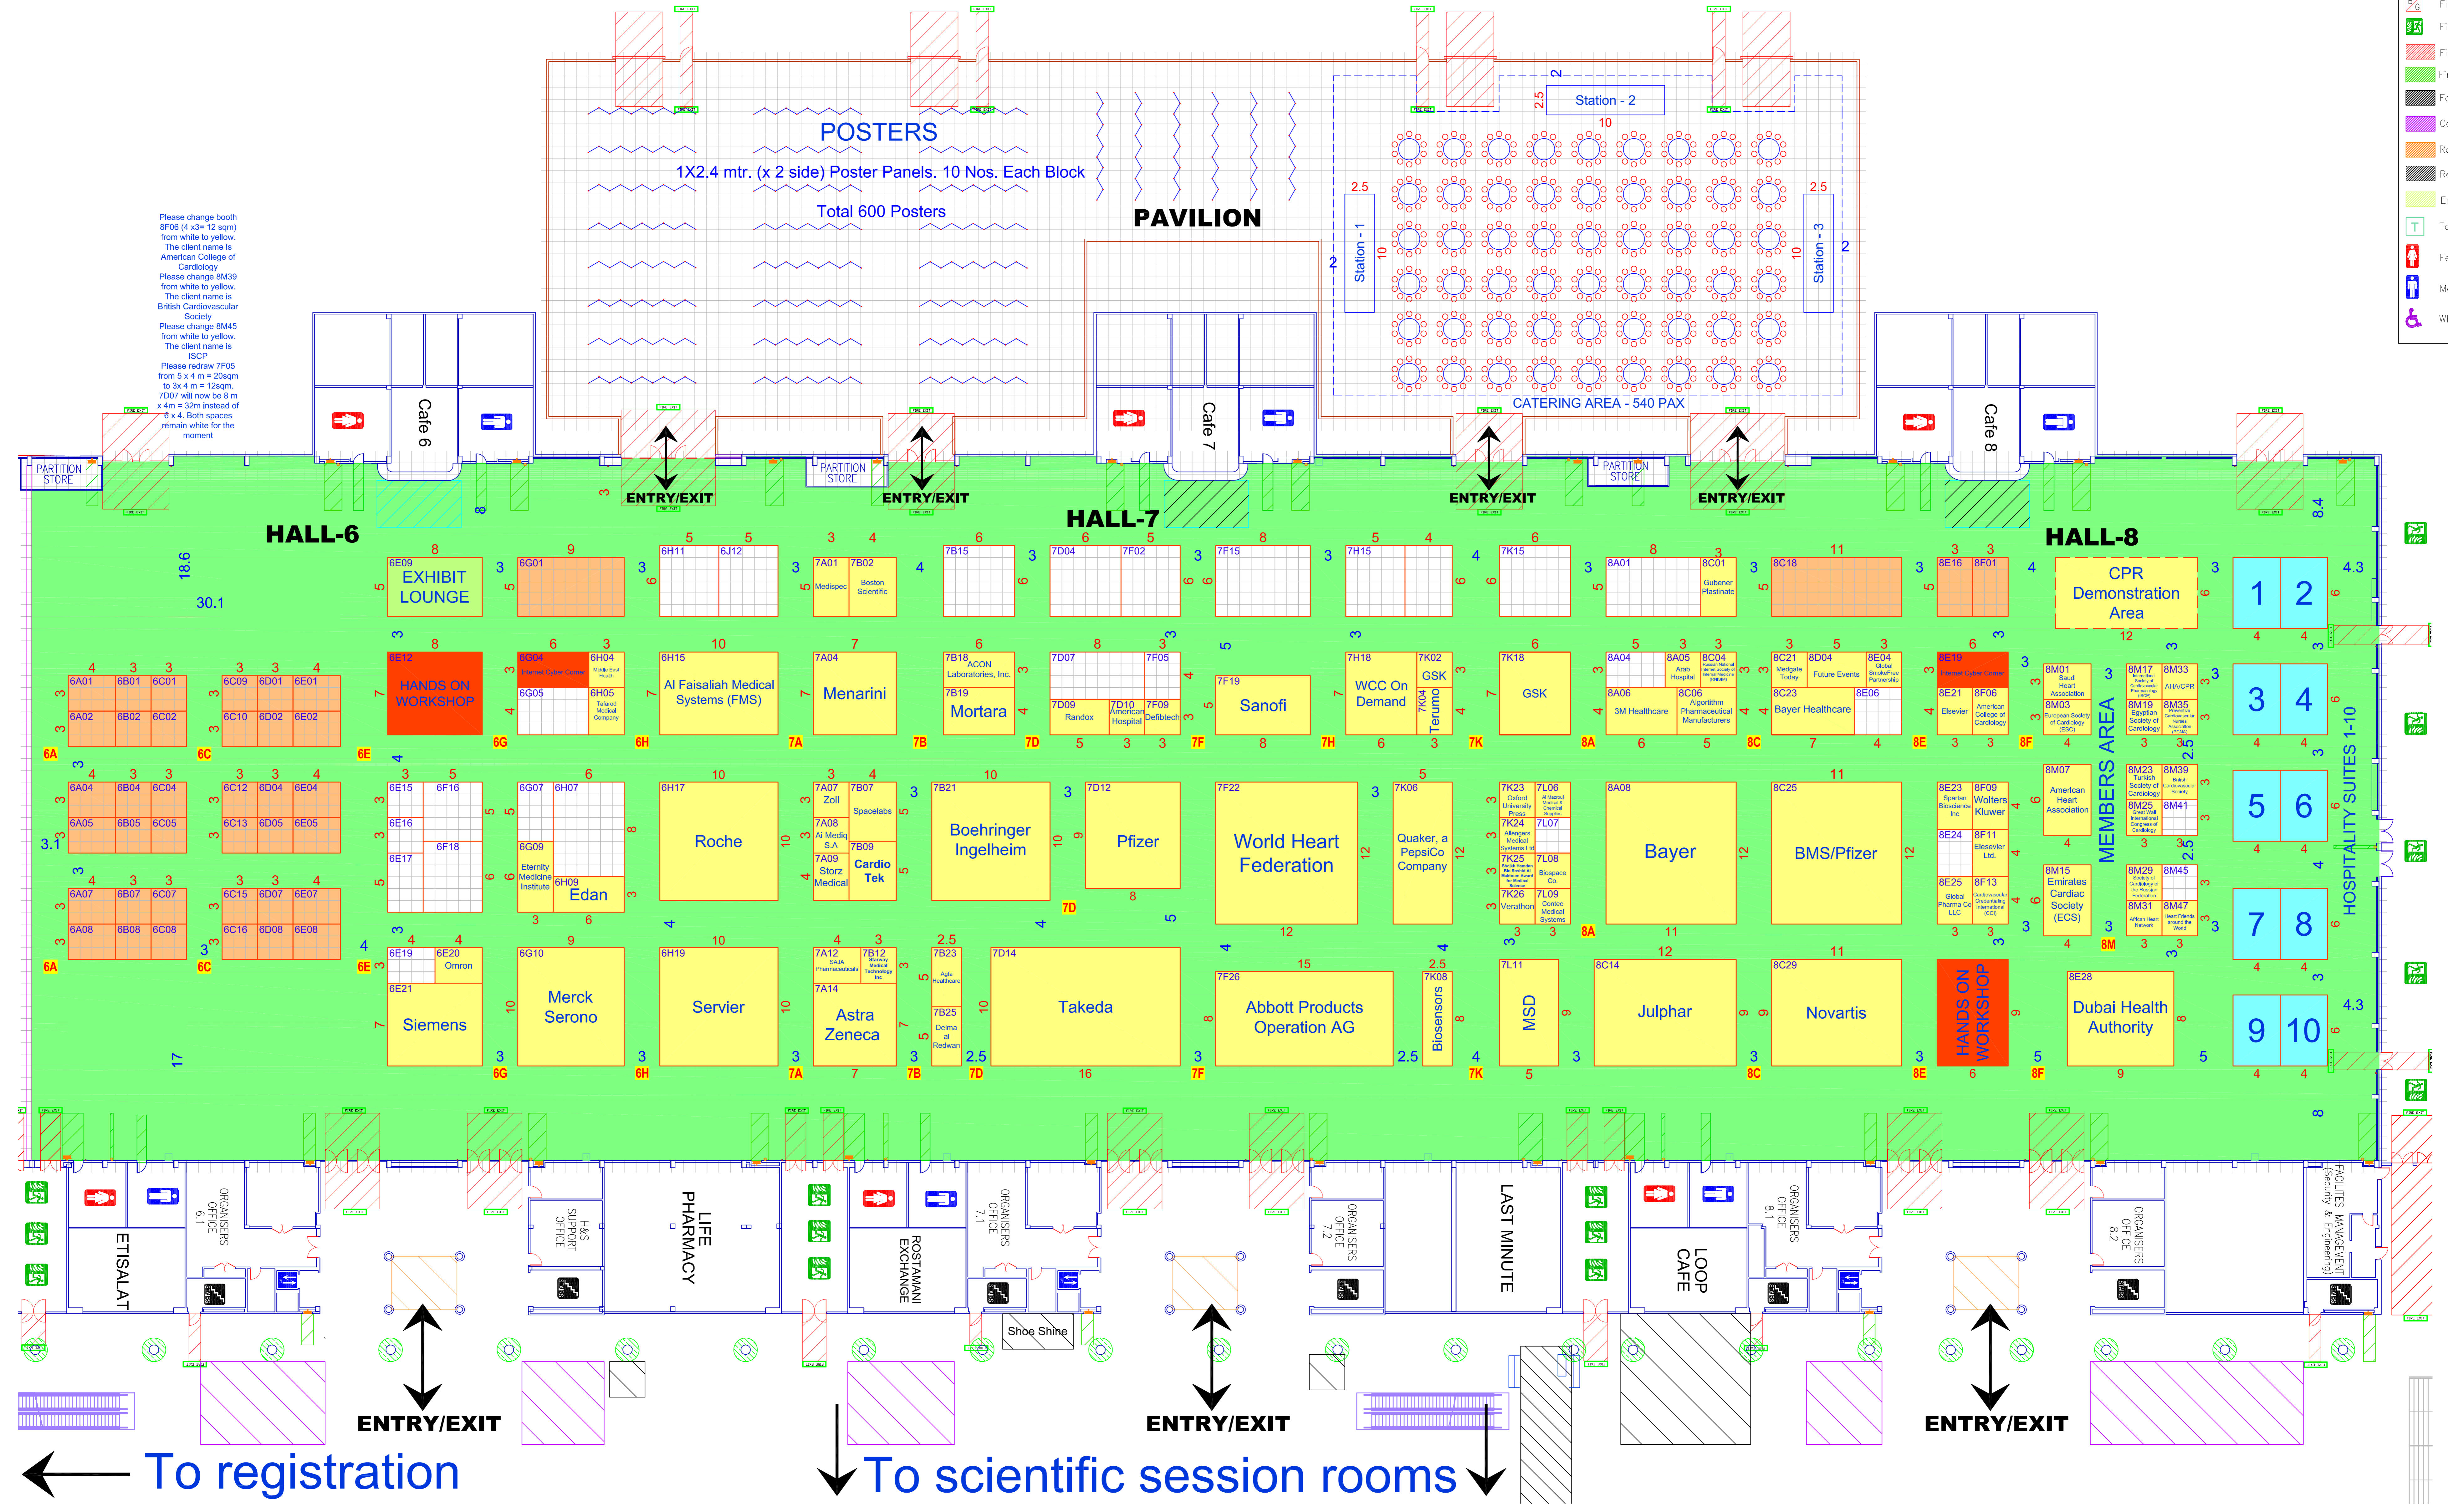

Please change booth 8F06 (4x3= 12 sqm) from white to yellow. The client name is American College of Cardiology.
 Please change 8M39 from white to yellow. The client name is British Cardiovascular Society.
 Please change 8M45 from white to yellow. The client name is ISCP.
 Please redraw 7F05 from 3x4 m = 20sqm to 3x4 m = 12sqm. 7D07 will now be 8 m x 4 m = 32m instead of 9 x 4. Both spaces remain white for the moment.

FLOOR PLAN

Scale: 1: 600 mtr. on A3 size sheet
 Scale: 1: 300 mtr. on A1 size sheet
 Scale: 1: 200 mtr. on A0 size sheet
 GRID SIZE: 1x1 mtr.

Updated on 14 FEB 2012 - a

Client: World Heart Federation	Project :	Scale:	Detailed by:	Drawing Title:		Remarks:	
	World Congress of Cardiology 2012	As Shown	MRF				
Project Location: DUBAI WORLD TRADE CENTRE	Customer Service Person:	Client Approval:	Designed by:	Job No:	Dwg No:	Revision:	Date:
			MRF		...	Rev-38	14 FEB 2012
			Approved by:	Sheet No:			
			RL				

This design/drawing is the property of PICO International (Dubai) LLC (PID) and cannot be copied or modified wholly or partially without PID's written consent. This drawing is subject to modification to suit construction purposes.